


Coordinate System: NAD 1983 StatePlane New York East FIPS 3101 Feet, Map Rotation: 0
-- Saved By: AKAILAS on 11/18/2024, 13:50:42 PM, File Path: I:\employees\glengis\proj\h-PROJECTS\ConnectGEN\411360-Mill_Point_Solar\2-APRX\Mill_Point_94C_EX24.aprx, Layout Name: MP1, Figure, T_Lighting, Contours, ftx17L

 


- FACILITY SITE
 - PROPERTY LINES
 - TOWN BOUNDARY
 - LIGHTING CONTOURS (CANDELA)
- PROJECT COMPONENTS**
- O&M BUILDING
 - SUBSTATION
 - POI SWITCHYARD
 - PROPOSED FENCE LINE

BASE MAP: ESRI WORLD IMAGERY SERVICE (3/30/2022)
DATA SOURCES: ESRI, USGS, NYS GIS, TRC.

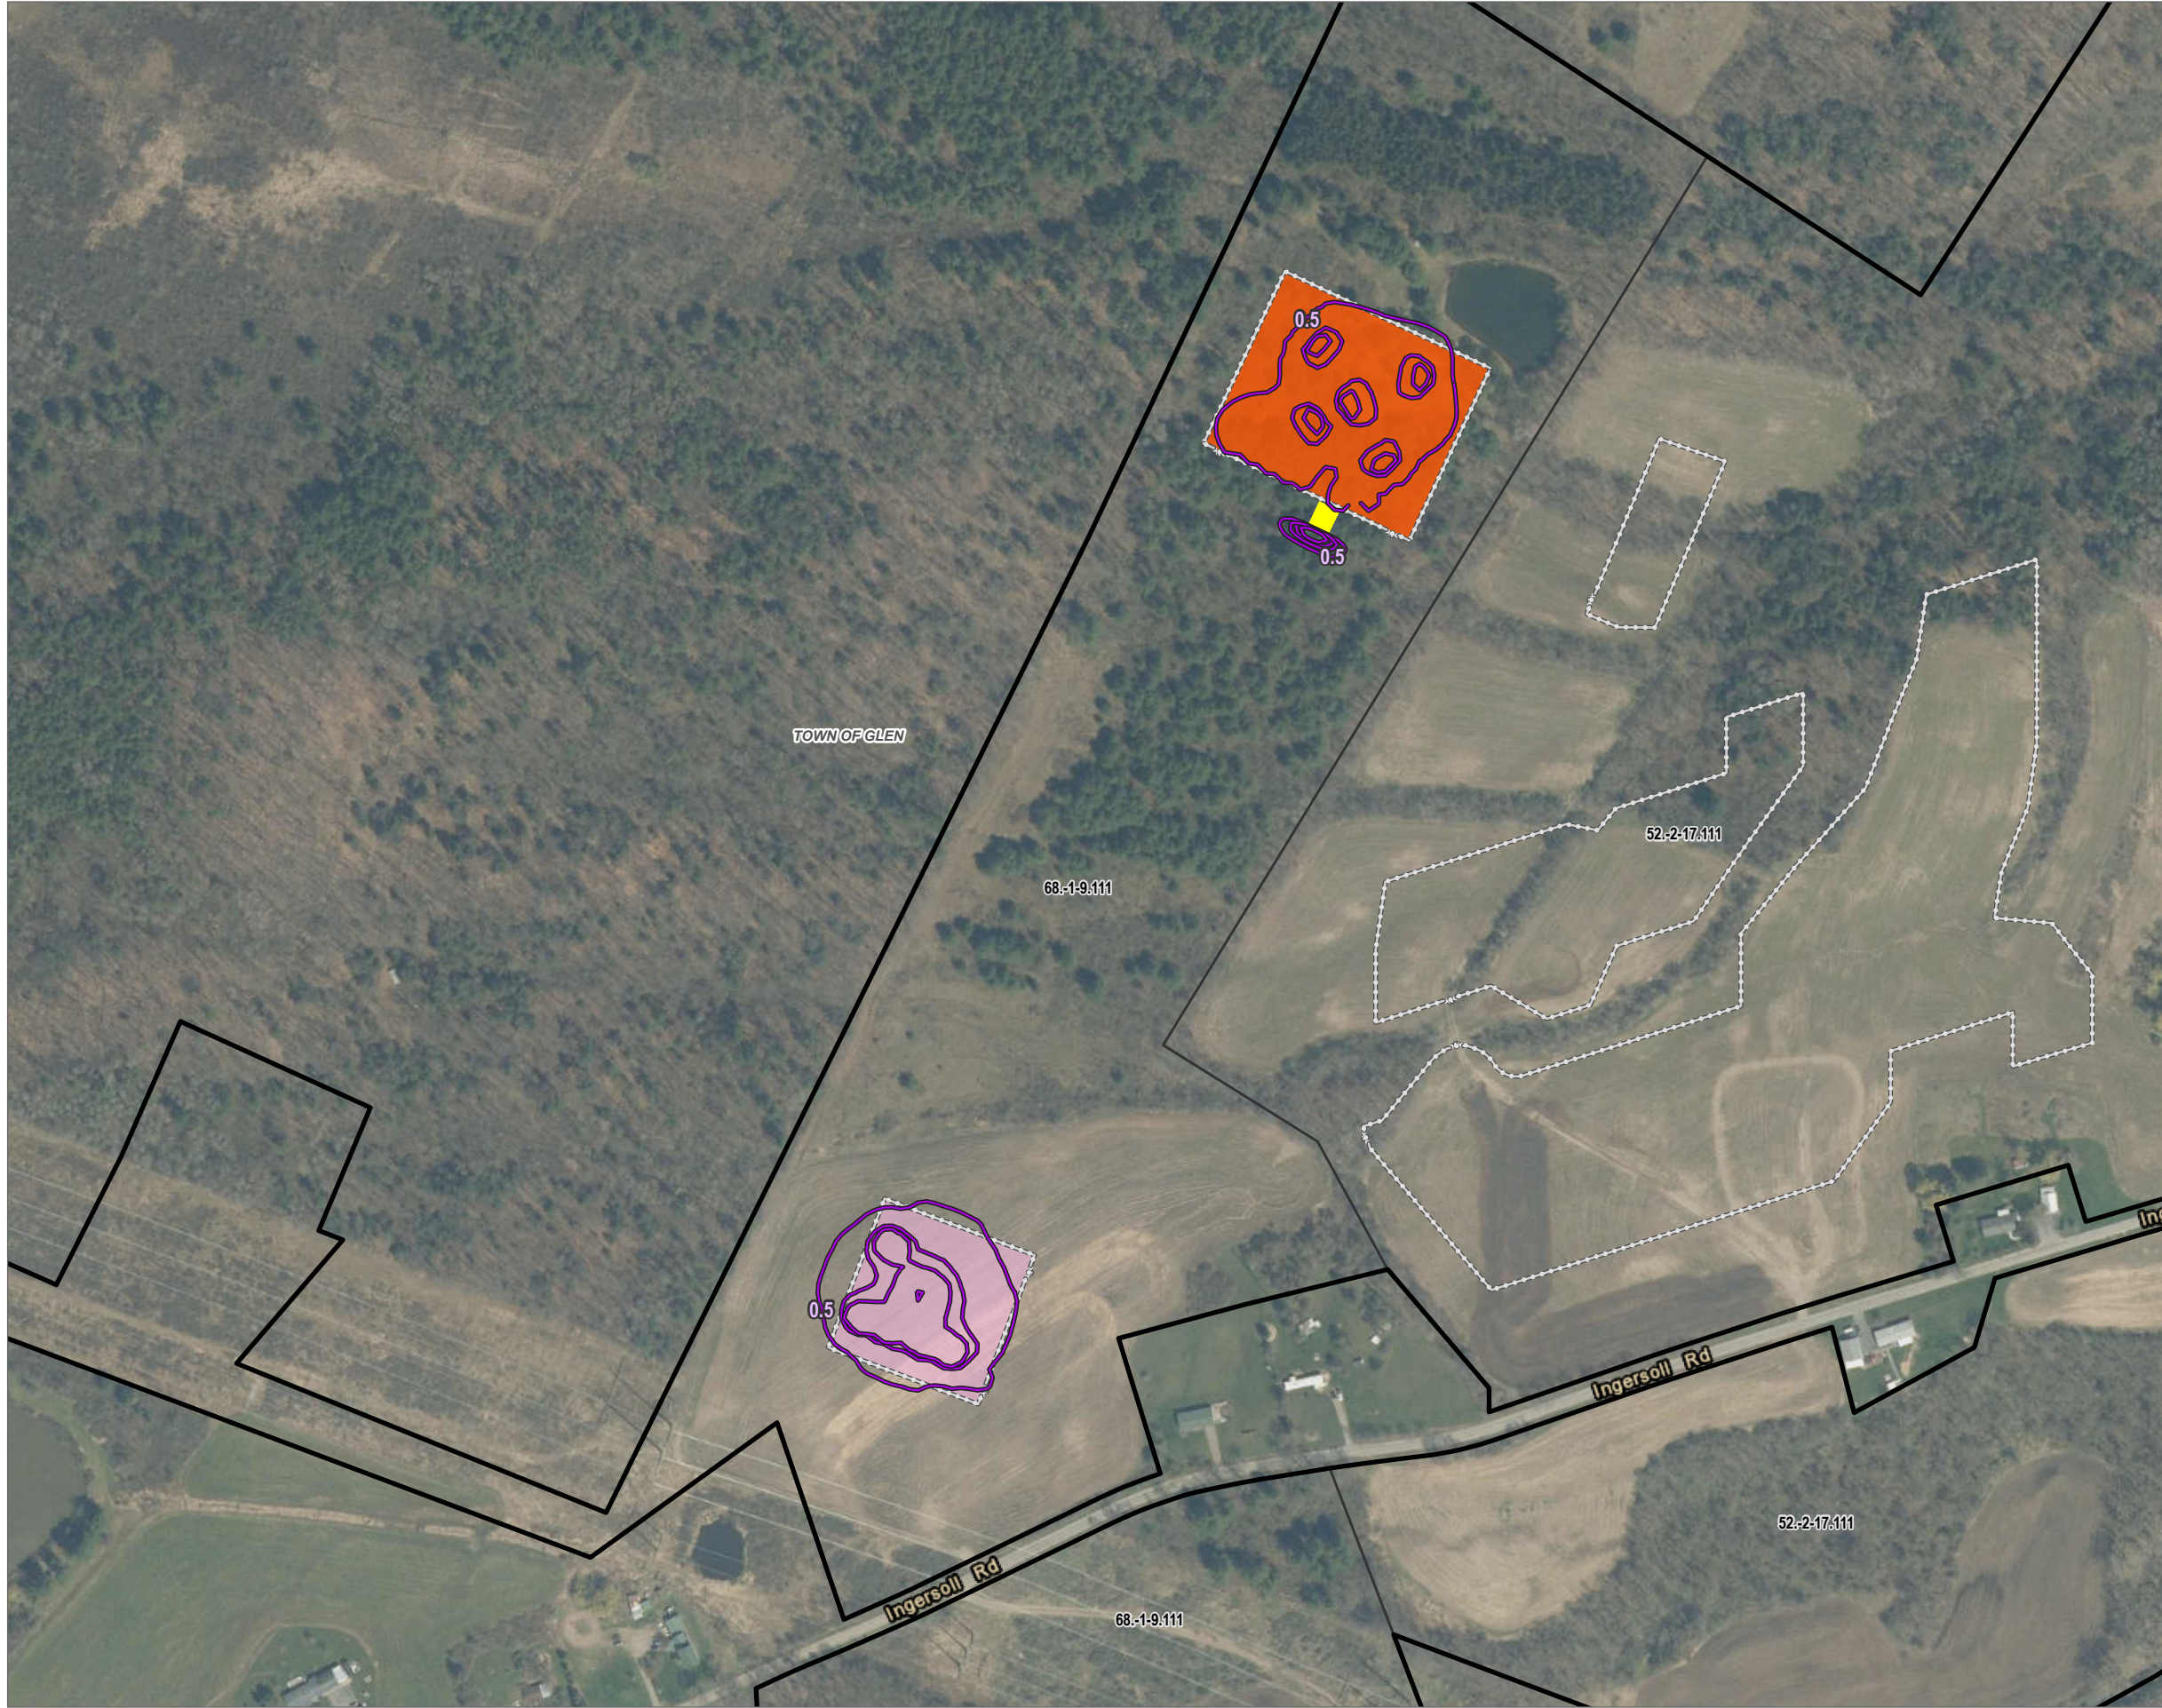

1:3,600
1" = 300 Feet



PROJECT:		CONNECTGEN MONTGOMERY COUNTY LLC MILL POINT SOLAR I TOWN OF GLEN, MONTGOMERY COUNTY, NY	
TITLE:		LIGHTING PLAN CONTOURS	
DRAWN BY:	A. KAILAS	PROJ. NO.:	411360
CHECKED BY:	C. PEARCE	FIGURE 24-1	
APPROVED BY:	T. KONDAK		
DATE:	NOVEMBER 2024		
		3 CORPORATE DRIVE SUITE 202 CLIFTON PARK, NY 12065 PHONE: 518.348.1190	
FILE:		MILL_POINT_94C_EX24APRX	